



VILLAS ARE WITHOUT GARAGE FALSE CEILING			
Package	Cluster #	Plot #	Total # of Villas
2	1	J4V041 to J4V056	16
2A		F4V001 to F4V028	28
	3	E4V051 to E4V062	12
	4	E4V027 to E4V050	24
	5	H4V001 to H4V017	17
	7	D4V042 to D4V050	9
	8	D4V019 to D4V032	14
	9	A4V012 to A4V029	18
	10	A4V030 to A4V044	15
	11	D4V001 to D4V018	18
	12	C4V047 to C4V062	16
	13	C4V001 to C4V0013	13
		C4V036 to C4V0046	11
	14	C4V014 to C4V0035	22
	15	B4V001 to B4V0014	14
	16	G4V001 to G4V017	17
Total Villas			264 Villas

VILLAS ARE WITH EXHAUST FAN IN PANTRY			
Package	Cluster #	Plot #	Total # of Villas
2	2	J4V021 to J4V040	20
	3	J4V001 to J4V020	20
	4	I4V019 to I4V028	10
	5	I4V001 to I4V018	18
	6	K4V034	13
		K4V040 to K4V046	
	8	L4V049	1
Total Villas			82 Villas

VILLAS ARE WITHOUT EXHAUST FAN IN PANTRY			
Package	Cluster #	Plot #	Total # of Villas
2	1	J4V041 to J4V056	16
	6	K4V035 to K4V039	5
	7	K4V019 to K4V028	10
	8	L4V039 to L4V048	10
2A	1	F4V001 to F4V028	28
	3	E4V051 to E4V062	12
	4	E4V027 to E4V050	24
	5	H4V001 to H4V017	17
	7	D4V042 to D4V050	9
	8	D4V019 to D4V032	14
	9	A4V012 to A4V029	18
	10	A4V030 to A4V044	15
	11	D4V001 to D4V018	18
	12	C4V047 to C4V062	16
	13	C4V001 to C4V0013	13
		C4V036 to C4V0046	11
	14	C4V014 to C4V0035	22
	15	B4V001 to B4V0014	14
16	G4V001 to G4V017	17	
Total Villas			289 Villas

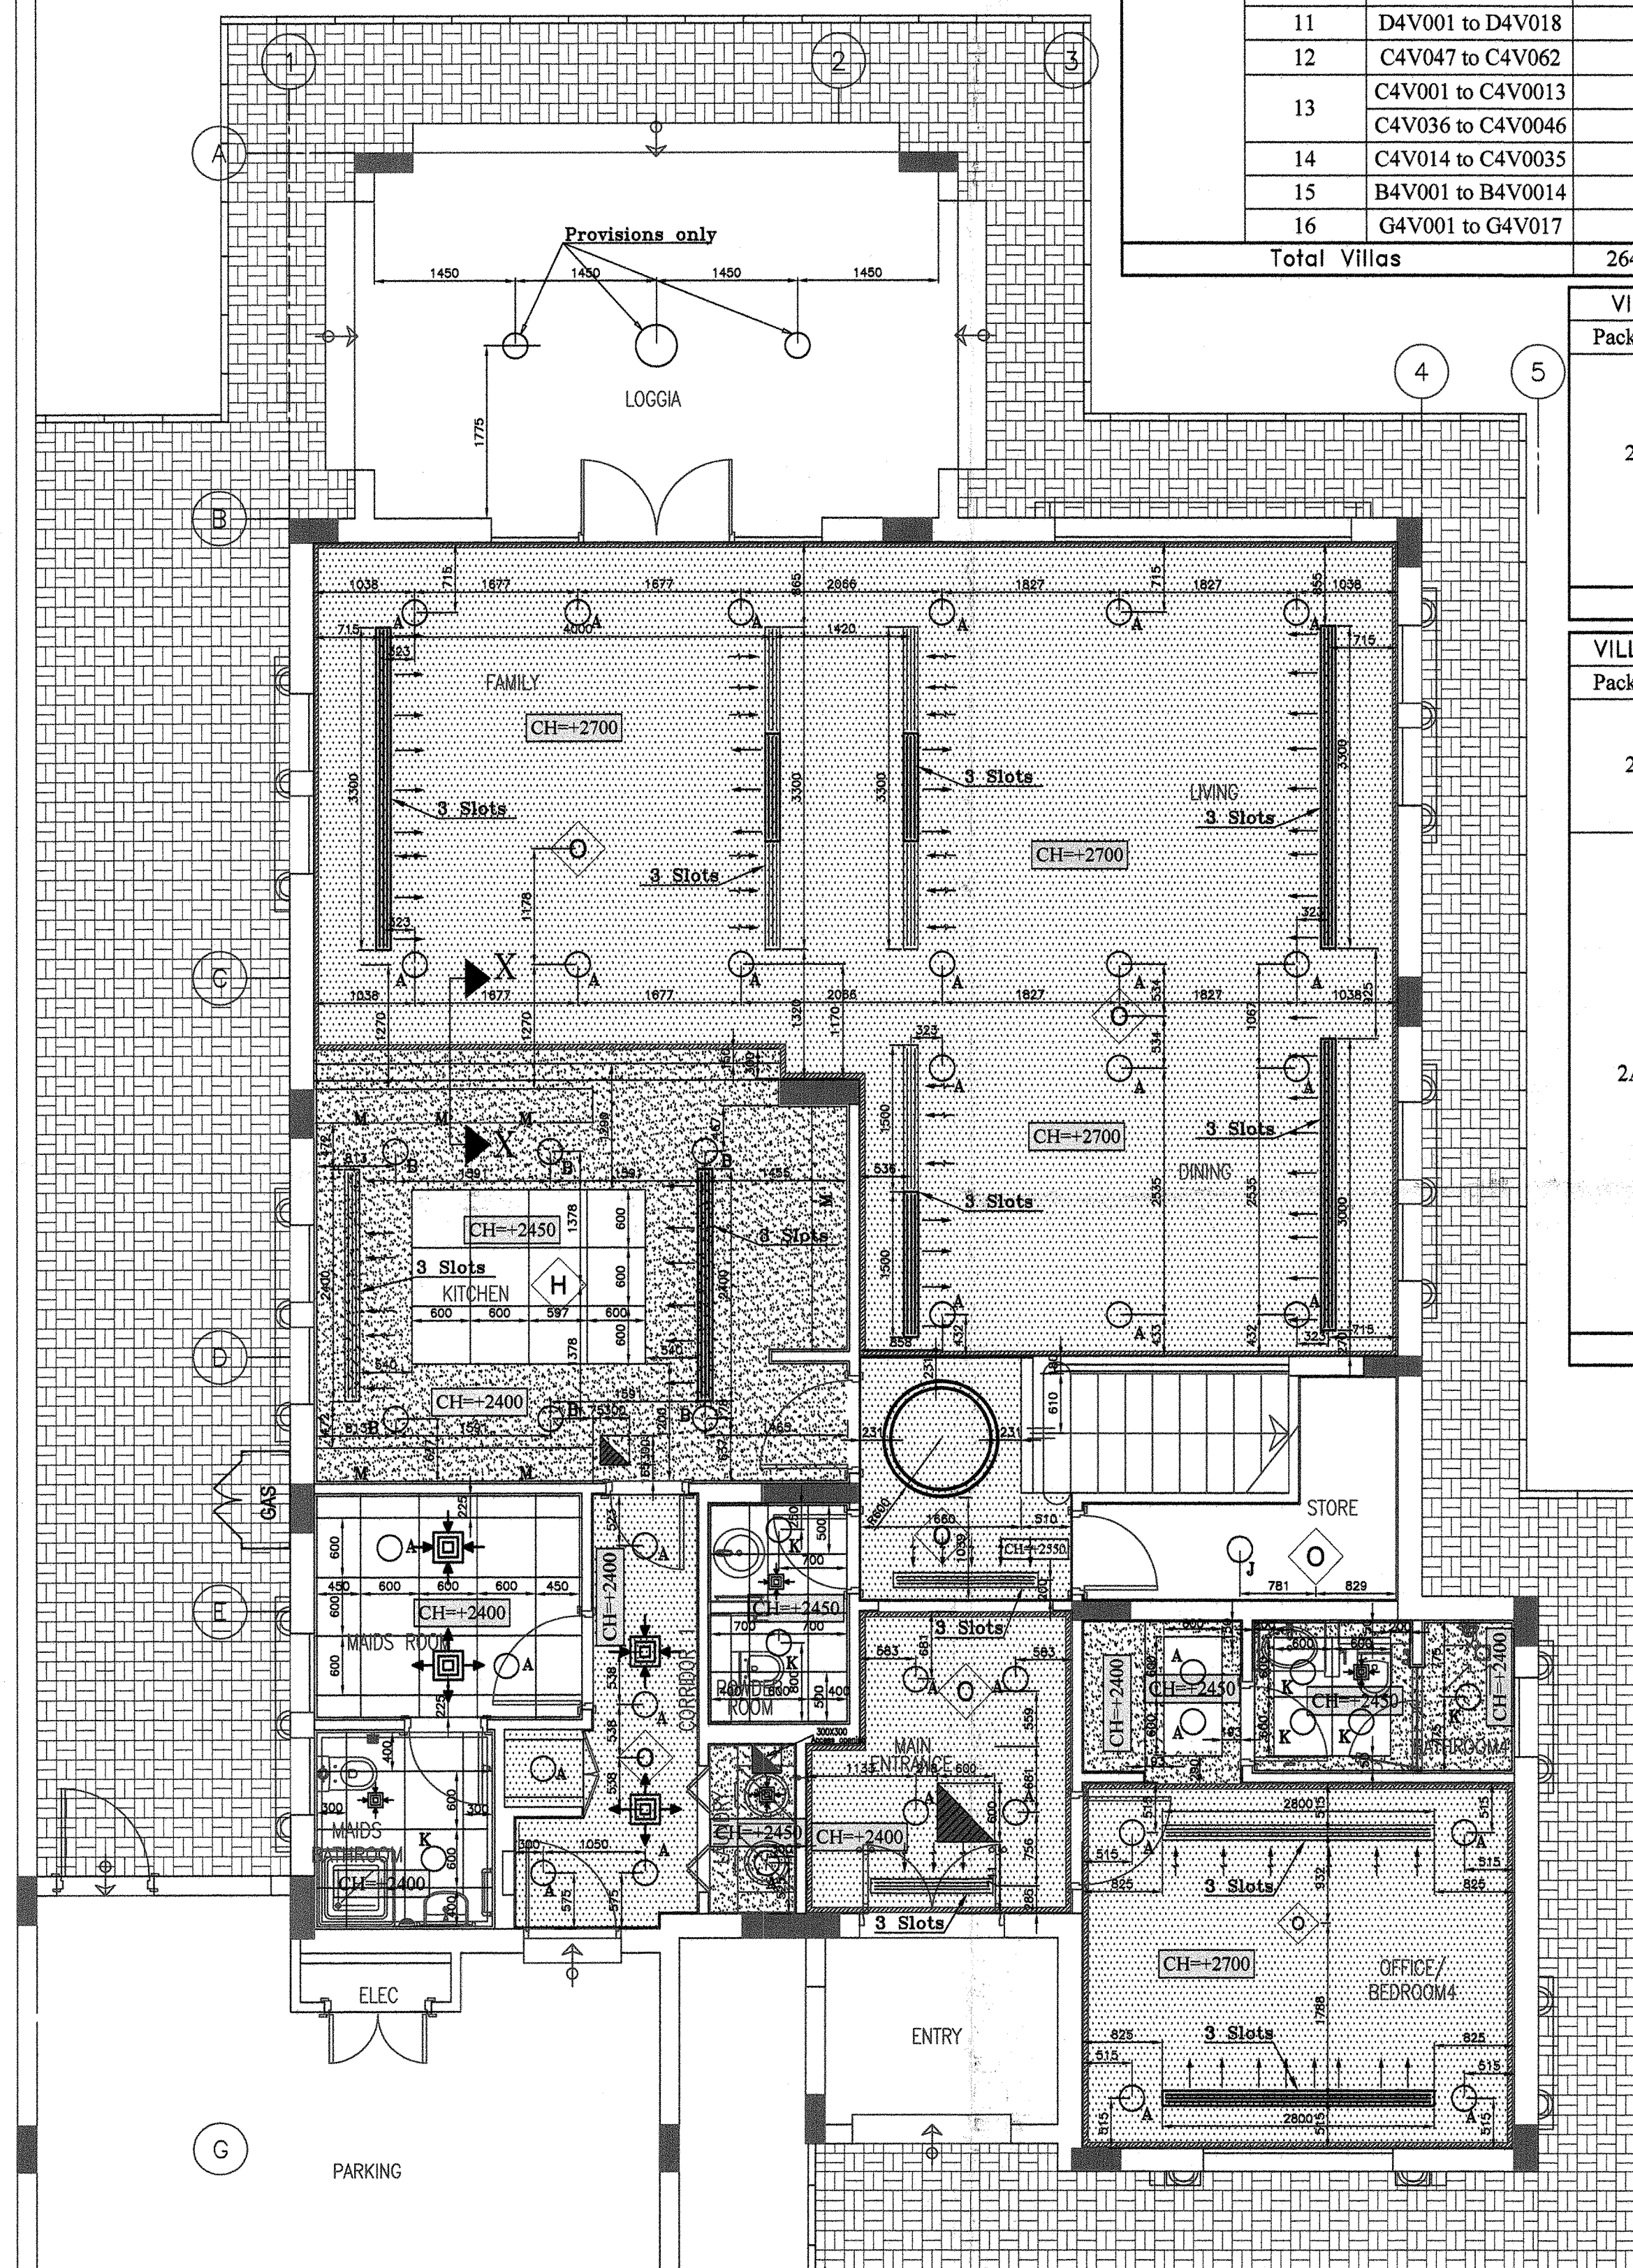

GROUND FLOOR PLAN
REFLECTED CEILING PLAN

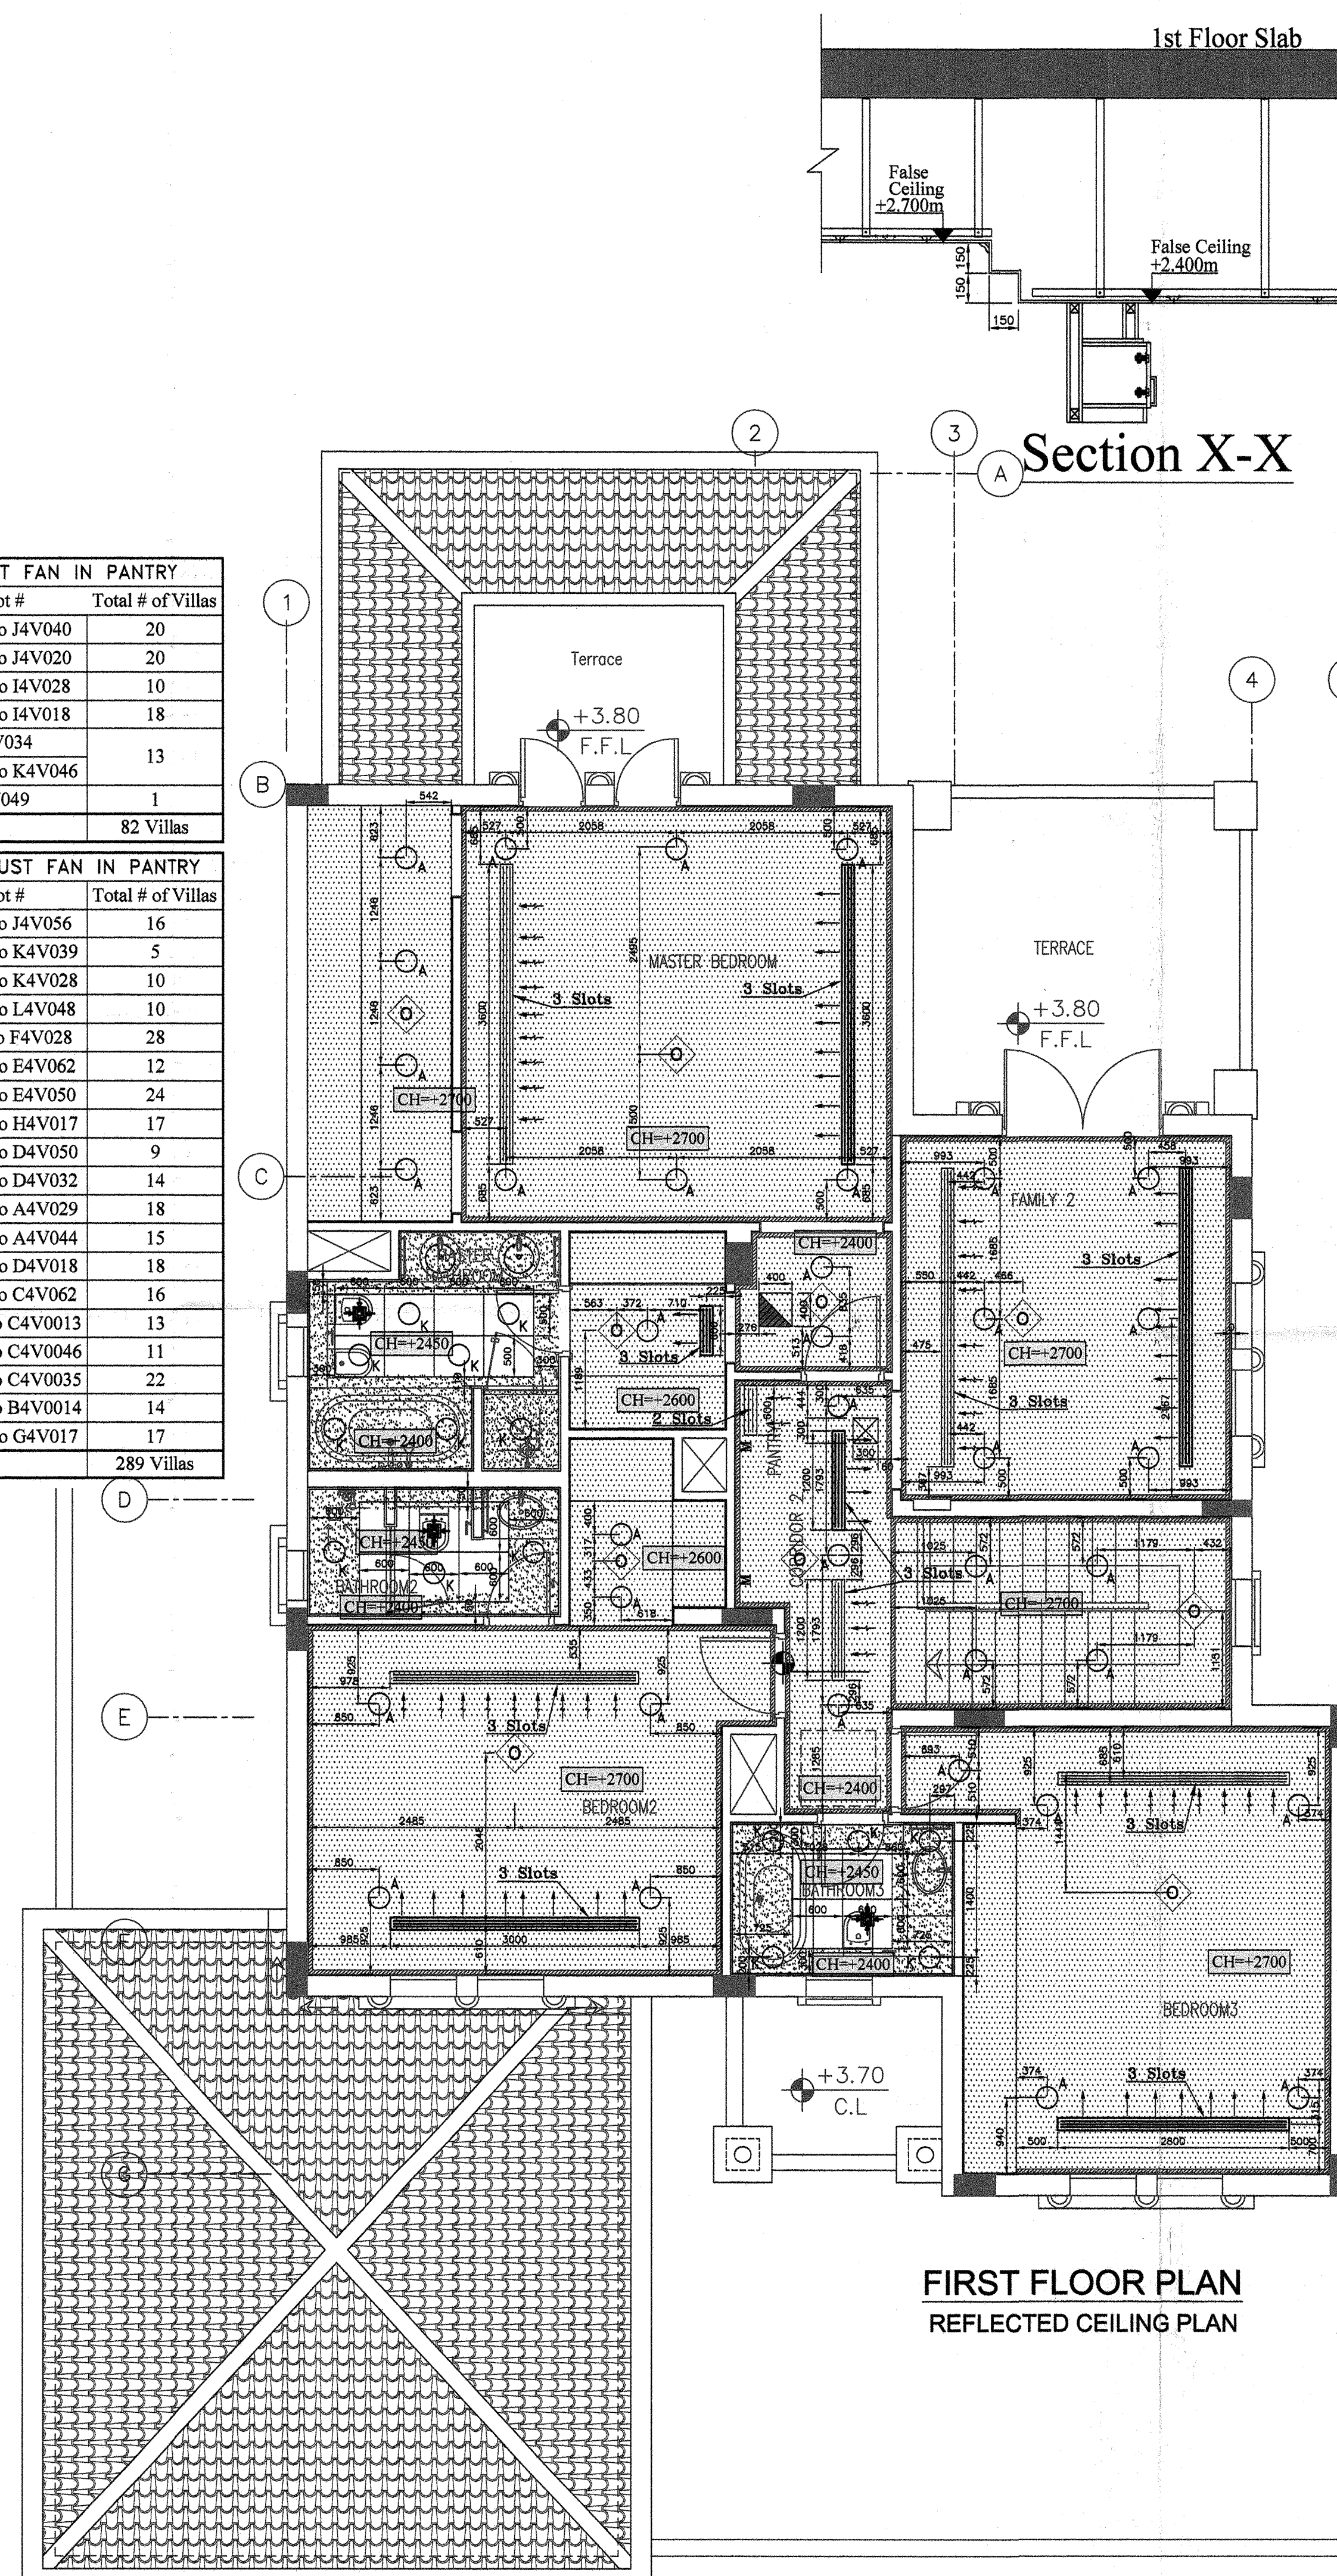

FIRST FLOOR PLAN
REFLECTED CEILING PLAN

LEGENDS:						
LOCATION	SYMBOL	DESCRIPTION	MAKE / CAT. NO.	MOUNTING HEIGHTS(mm)	QUANTITY	REMARKS
		12.5MM THICK REGULAR OPSYSM BOARD.				
		12.5MM THICK MOISTURE RESISTANT OPSYSM BOARD.				
		TILES 600 X 600				
		9mm CEMENT BOARD.				
GARAGE PARKING						
LAUNDRY ROOM, WASH ROOM & DRY AREAS EXCEPT WASH ROOM		RECESSED DOWNLIGHT DD-CAT ALUMINUM HOUSING 120W/12V, 10' HALOGEN LAMP. (P43) GLASS DIFFUSER	REGGIAN 3485.1	ON FALSE CEILING	36	
KITCHEN LIGHTING		RECESSED DOWNLIGHT HOUSING 150W/12V, LOW VOLTAGE HALOGEN LAMP. (P43)	REGGIAN 3487.1	ON FALSE CEILING	8	
BATH TUBS&SHOWER AREAS		RECESSED DOWNLIGHT HOUSING 150W/12V, LOW VOLTAGE HALOGEN LAMP. (P43)	REGGIAN 379.8.1	ON FALSE CEILING	1	
STORE		SURFACE MOUNTED FUTURE HOUSING, 12V/1W COMPACT FLUORESCENT LAMP. INSULATION CASE 1 IP 56.	REGGIAN H400P 789	ON FALSE CEILING	1	
LOGGA INTERNAL LIGHTING DRY EXTERNAL LIGHTING		SURFACE MOUNTED FUTURE HOUSING 12V/1W COMPACT FLUORESCENT LAMP. (P43) LESS STEEL/ALUMINUM DULUX STAR 789/85	REGA 60040	2200mm FROM F.F.L	10	
MAIN ENTRANCE		SURFACE MOUNTED HOUSING 120W/12V, 10' HALOGEN LAMP. (P43)	WESTGORT 20752 147469	2200mm FROM F.F.L	1	
POWDER ROOM		NULL MOUNTED HOUSING 120W/12V, 10' HALOGEN LAMP. (P44)	WESTGORT 20752 147469	1800mm FROM F.F.L	1	
MAIN GATE COLUMNS TOP		PULAR LAMINARE HOUSING 120W/12V, COMPACT FLUORESCENT LAMP. IP 44.	IP 44 BOMBAY SHEL	2200mm FROM F.F.L	2	
PARKING EXTERNAL LIGHTING		NULL MOUNTED GROUND ALUMINUM & STAIN LESS STEEL/ALUMINUM DULUX STAR DIFFUSER 120W TO-2, 1200W.	REGA 2385	2200mm FROM F.F.L	2	
KITCHEN WARD ROBS		SURFACE MOUNTED FUTURE HOUSING 100W/12V, 10' WITH ACRYLIC DIFFUSER.			6	
		LIGHTING OUTLET PANEL (OPTION)			7	TYPE OF LIGHT
LOGGA		CEILING FAN PANEL (PROVISION)		ON CEILING	2	
		CEILING FAN PROVISION		CEILING	1	
		ULTRASONIC OCCUPANCY SENSOR		ON CEILING	1	
PARKING&PUMP ROOM		SURFACE MOUNTED, PRISMATIC POLYCARBONATE DIFFUSER 120W/12V, 10' P43.	25LUX ALFONZA 1200-200005	3400mm FROM F.F.L	5	
		SINGLE STATION RESIDENTIAL SMOKE DETECTOR		ON CEILING	6	
		SINGLE STATION RESIDENTIAL FIXED TEMPERATURE HEAT DETECTOR		ON CEILING	1	
		RETURN CEILING DIFFUSER		ON CEILING	6	
		SUPPLY CEILING DIFFUSER		ON CEILING	2	
		SUPPLY FLOW BAR DIFFUSER		ON CEILING	17	
		RETURN FLOW BAR DIFFUSER		ON CEILING	8	
		ACCESS PANEL(PERMANENT)		ON OPSYSM	3	
		TEMPORARY ACCESS HATCH		ON OPSYSM	9	

ALL FALSE CEILING LEVELS ARE AFTER FINISHED FLOOR LEVEL (AFFL)

	 dar al-hadrasah Sukuk and Partners
☒ CODE 1	APPROVED
☐ CODE 2	APPROVED AS NOTED WORK MAY PROCEED WITH "O" RECOMMENDATIONS OF ENDORSEES COMMENTS
☐ CODE 3	RESUBMIT FOR APPROVAL WORK MAY NOT PROCEED
☐ CODE 4	REJECTED

BY: _____ DATE: _____

A personal liability will adhere the Contractor to complete the submission of any of his obligations under the Contract or compliance with the obligation of any change to Contract's requirements in accordance to the terms.

Civilian is responsible for Client's, consultant and coordination with other trades.

AS BUILT DRAWING

PROJECT **JUMEIRAH PARK**

EMPLOYER



NAKHEEL
EMIRATES TOWERS
19th LEVEL
P.O.BOX - 17777
DUBAI - UAE
TEL : 04-3903388
FAX : 04-3903335

CONSULTANT



dar al-handasah
shair and partners

MAIN CONTRACTOR	
-----------------	--



Pauling Middle East Co. L.L.C.

	SUB CONTRACTOR
--	----------------

STANDARD

BUILDING MATERIALS TRADING L.L.C
TEL: 02-6774225 FAX: 02-6789273. POST BOX NO. 43135 ABU DHABI, UAE.

PACKAGE

PACKAGE - 2 & 2A

LEGACY

MEP CONTRACTOR



electrical and mechanical works
P.O. Box 31377, Dubai U.A.E
Tel: 3966771 Fax: 3966772

DRAWING TITLE

REFLECTED CEILING PLAN LEGACY

SCALE	DATE	DRAWN BY	CHECKED BY
N.T.S	07-08-2012	T.MURUGAN	ENG. ZIAD

PME/JP/AB/LEGACY/RFC-001A