



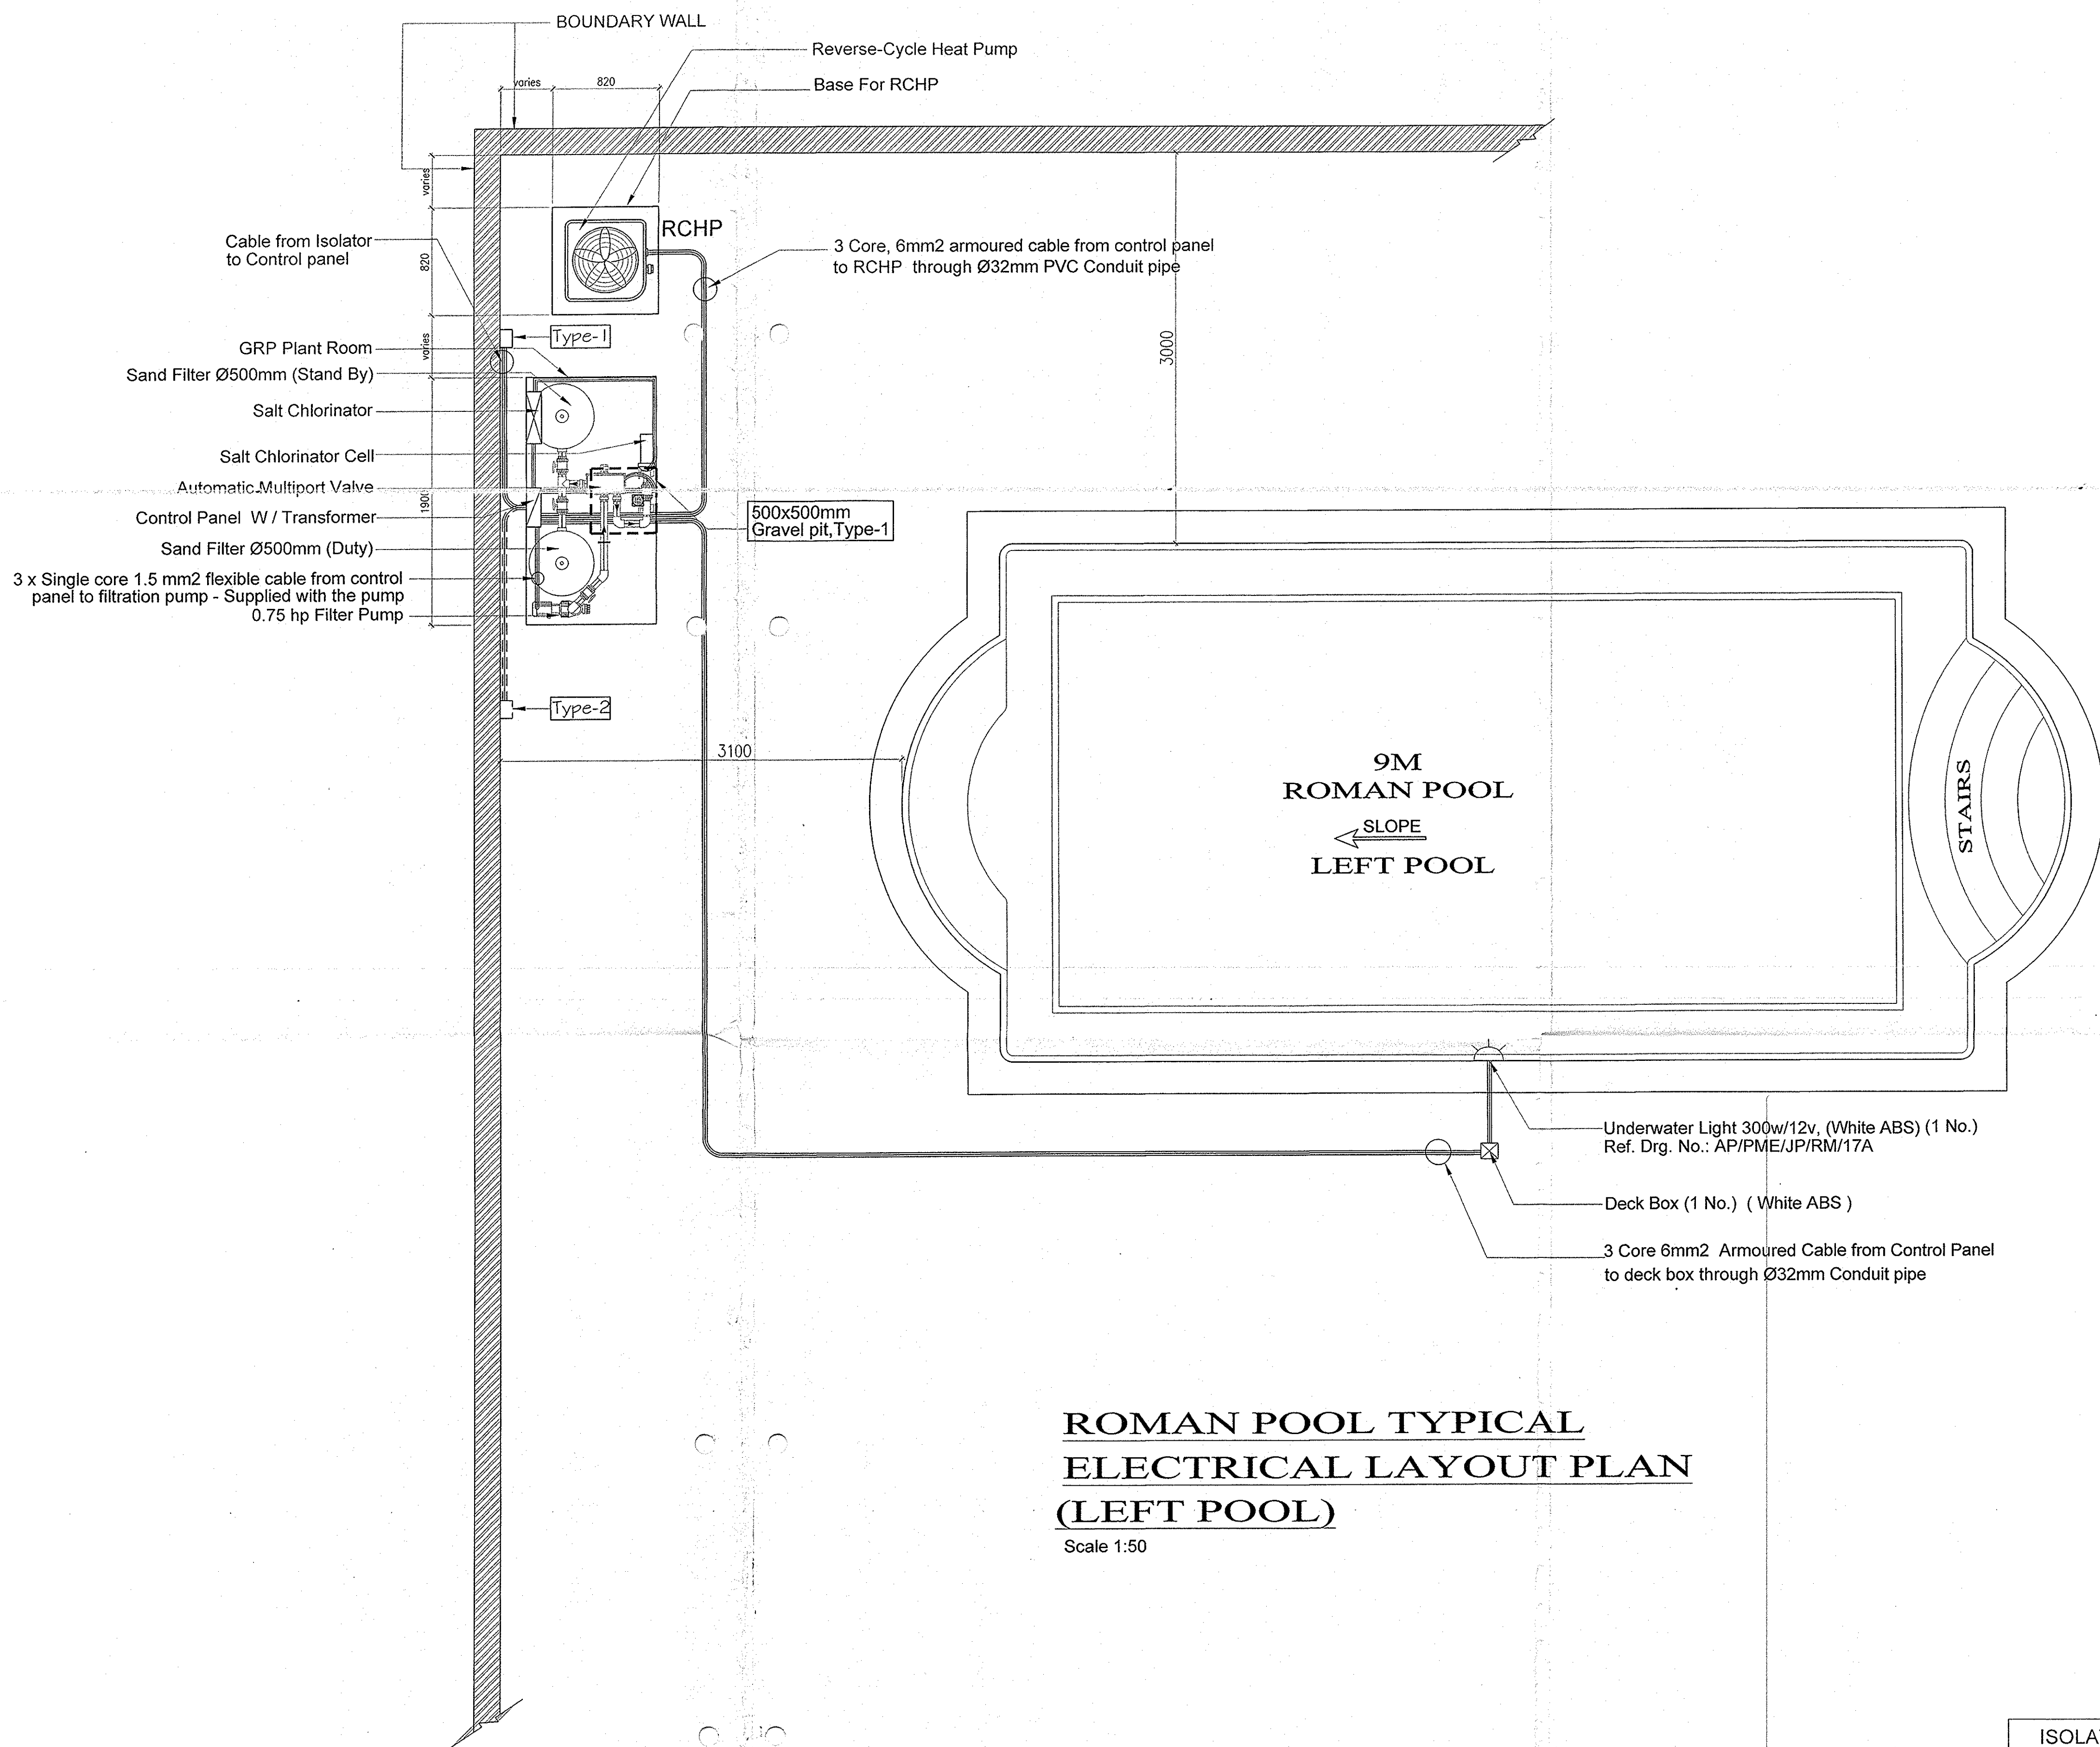

LEGEND	POOL FITTINGS	QTY
	300w/12v UNDER WATER LIGHT (WHITE ABS) (Certikin)	1
	Deck Box (White ABS)	1

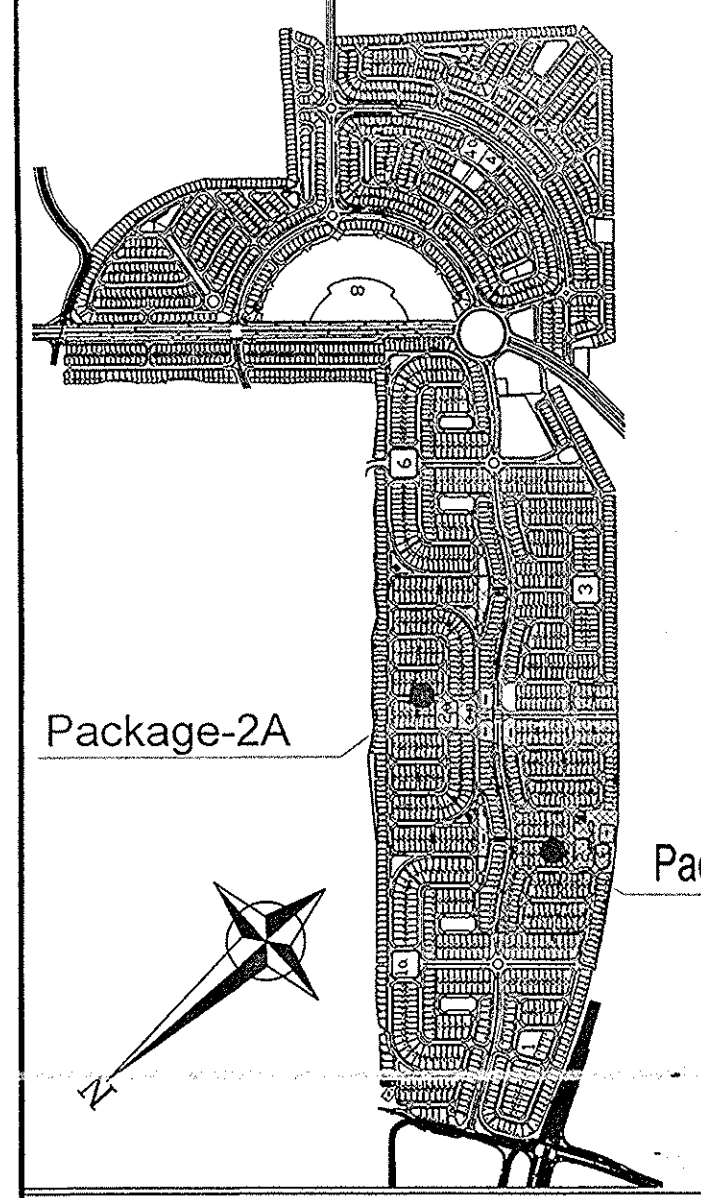

- NOTES:-**
- 1) ALL DIMENSIONS ARE IN MM .
 - 2) FOR SETTING OUT PLAN OF SW. POOL ,PLANT ROOM
PL.REF. DWG. NO. AP/PME/JP/RM/26A-26J FOR PACKAGE-2A
PL.REF. DWG. NO. AP/PME/JP/RM/21A-21F FOR PACKAGE-2B
 - 3) FOR SETTING OUT PLAN OF POOL SIZE:- 9x4x1.1m-1.5m
@ PACKAGE - 2A, CLUSTER-2,VILLA # A4V - 03
Ref: Drg.No. AP/PME/JP/AB/RM/SK-07
 - 4) FOR SETTING OUT PLAN OF POOL SIZE:- 8x4x1.1m-1.5m
@ PACKAGE - 2A, CLUSTER-2,VILLA # A4V - 04&05
Ref.Drg.No.AP/PME/JP/AB/RM/SK-03 & 05
 - 5) FOR SETTING OUT PLAN OF POOL SIZE:- 6.25x4x1.1m
@ PACKAGE - 2A, CLUSTER-10,VILLA # 40 - 44
Ref. Drg.No. AP/PME/JP/AB/RM/SK-10

Rev.	Date	Description	Drawn
AB2	25.06.12	ISSUED FOR APPROVAL	GS
AB1	22.02.12	ISSUED FOR APPROVAL	GS
AB	12.01.12	ISSUED FOR APPROVAL	GS



**ROMAN POOL TYPICAL
ELECTRICAL LAYOUT PLAN
(LEFT POOL)**
Scale 1:50

dar al-handasah
Sheir and Partners

☐ CODE 1 APPROVED
☐ CODE 2 APPROVED AS NOTED
WORK MAY PROCEED SUBJECT TO
INCORPORATION OF ENDORSED
COMMENTS.
☐ CODE 3 RESUBMIT FOR APPROVAL
WORK MAY NOT PROCEED
☐ CODE 4 REJECTED

BY: _____ DATE: _____

Approval shall not relieve the contractor of any of his obligations under the Contract or constitute authorization of any change to Contract Documents or variation to the work. Contractor is responsible for dimensions, quantities and coordination with other trades.

ISOLATOR LOCATION SCHEDULE				
PACKAGES	CLUSTERS	VILLAS	TYPE-1	TYPE-2
PACKAGES-2	2	27,28,29&30	✓	
PACKAGES-2	3	16,17&20	✓	
PACKAGES-2	REST ALL VILLAS			✓
PACKAGES-2A	REST ALL VILLAS			✓

AS BUILT DRAWING

JUMAIRAH PARK

NAKHEEL
P.O. BOX: 1777
PHONE: +971 4 3393155
FAX: +971 4 3393973
E-MAIL: info@nakheel.ae

dar al-handasah
sheir and partners
P.O. BOX: 1540
PHONE: +971 4 3393155
FAX: +971 4 3393973
E-MAIL: info@daralhandasah.ae

Pauling Middle East
P.O. BOX: 4510
PHONE: +971 4 3393155
FAX: +971 4 3393973
E-MAIL: info@pauling.ae

PACKAGE - 2 & 2A

absolute - pools
"The pool for the home owner"
P.O. BOX 48890, DUBAI, U.A.E
TEL: +971 4 3393155
FAX: +971 4 3393973
e-mail: info@absolute-pools.com

**ROMAN POOL TYPICAL
ELECTRICAL LAYOUT PLAN
Size:- 9m x 4m x 1.1m-1.5m Dep**

Drawn	GS	Review	RDL	Check	FM/1
Scale:	1:50	Date:	10-01-2012	Approved:	

Drawing No. _____

Drg. No.: AP/PME/JP/AB/RM/07A